


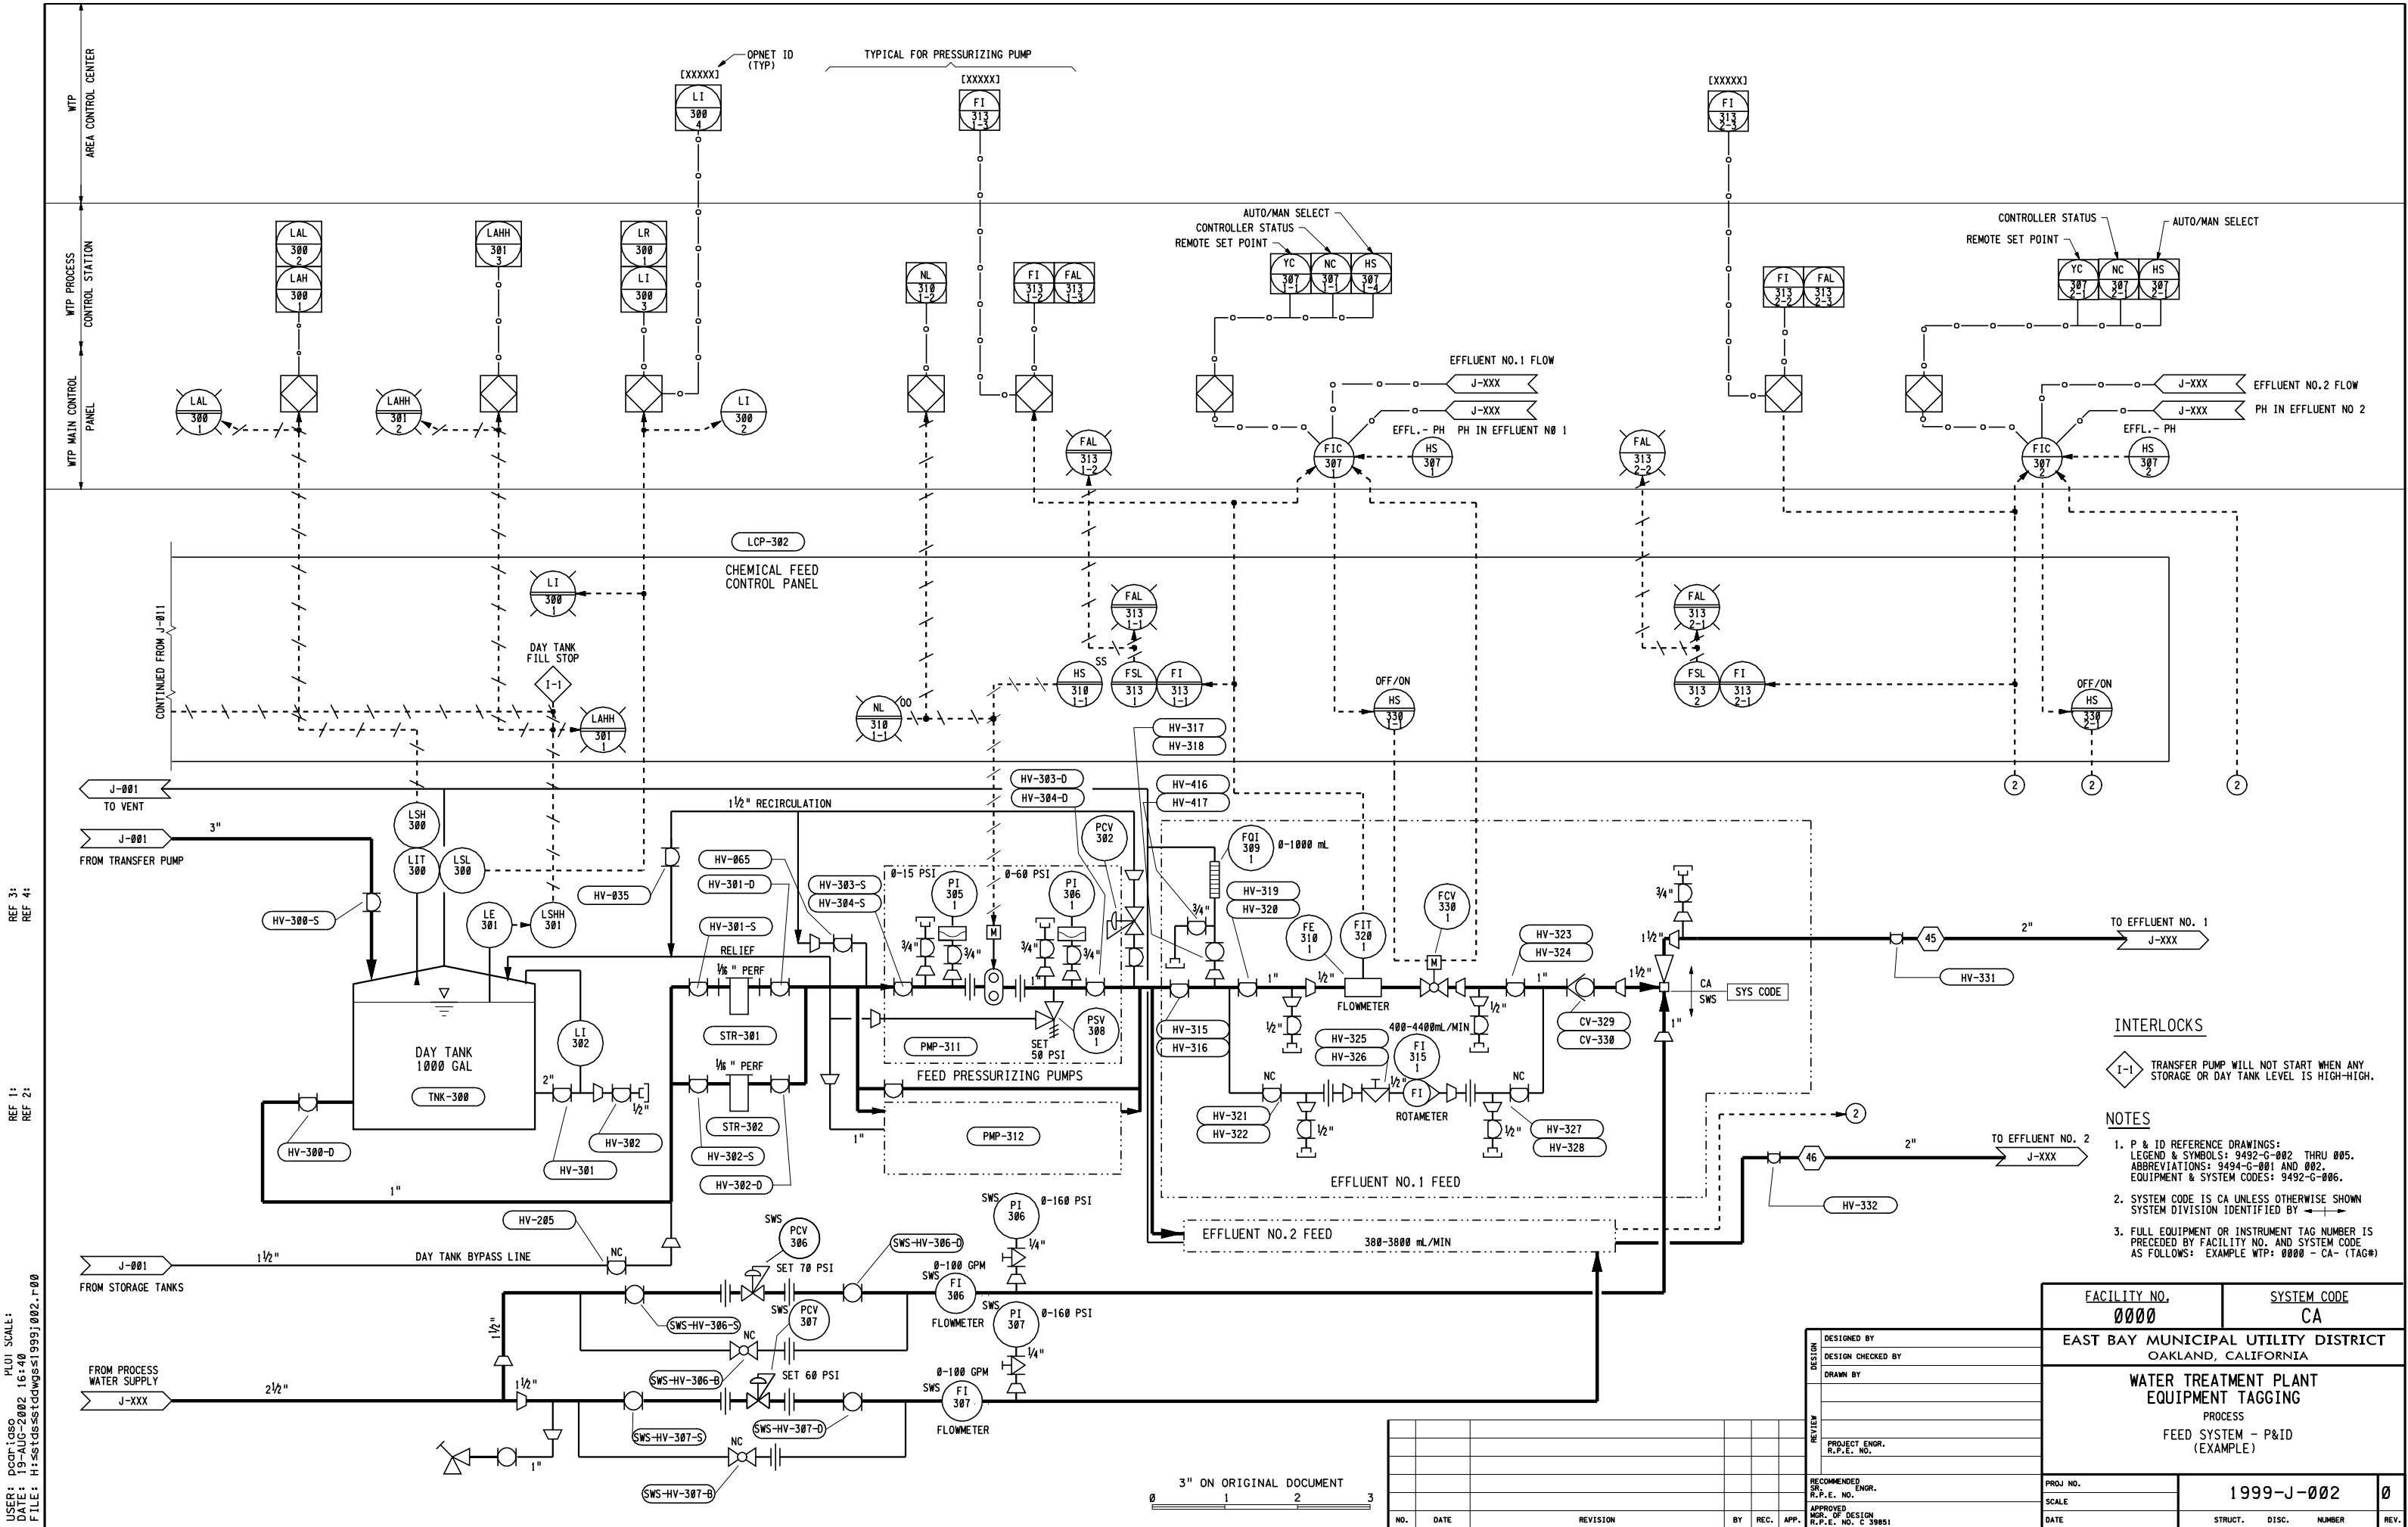

INTERLOCKS

I-1 TRANSFER PUMP WILL NOT START WHEN ANY STORAGE OR DAY TANK LEVEL IS HIGH-HIGH.

NOTES

1. P & ID REFERENCE DRAWINGS: LEGEND & SYMBOLS: 9492-G-002 THRU 005. ABBREVIATIONS: 9494-G-001 AND 002. EQUIPMENT & SYSTEM CODES: 9492-G-006.

2. SYSTEM CODE IS CA UNLESS OTHERWISE SHOWN. SYSTEM DIVISION IDENTIFIED BY CA.

3. FULL EQUIPMENT OR INSTRUMENT TAG NUMBER IS PRECEDED BY FACILITY NO. AND SYSTEM CODE AS FOLLOWS: EXAMPLE WTP: 0000 - CA- (TAG#)

FACILITY NO. 0000		SYSTEM CODE CA	
EAST BAY MUNICIPAL UTILITY DISTRICT OAKLAND, CALIFORNIA			
WATER TREATMENT PLANT EQUIPMENT TAGGING PROCESS FEED SYSTEM - P&ID (EXAMPLE)			
PROJ. NO.	1999-J-002		0
SCALE			
DATE	STRUCT.	DISC.	NUMBER
			REV.

DESIGNED BY	
DESIGN CHECKED BY	
DRAWN BY	
PROJECT ENGR.	
R.P.E. NO.	
RECOMMENDED	
S.R.P.E. NO.	
APPROVED	
MOR. OF DESIGN	
R.P.E. NO. C 30651	

NO.	DATE	REVISION	BY	REC.	APP.

3" ON ORIGINAL DOCUMENT

0 1 2 3